
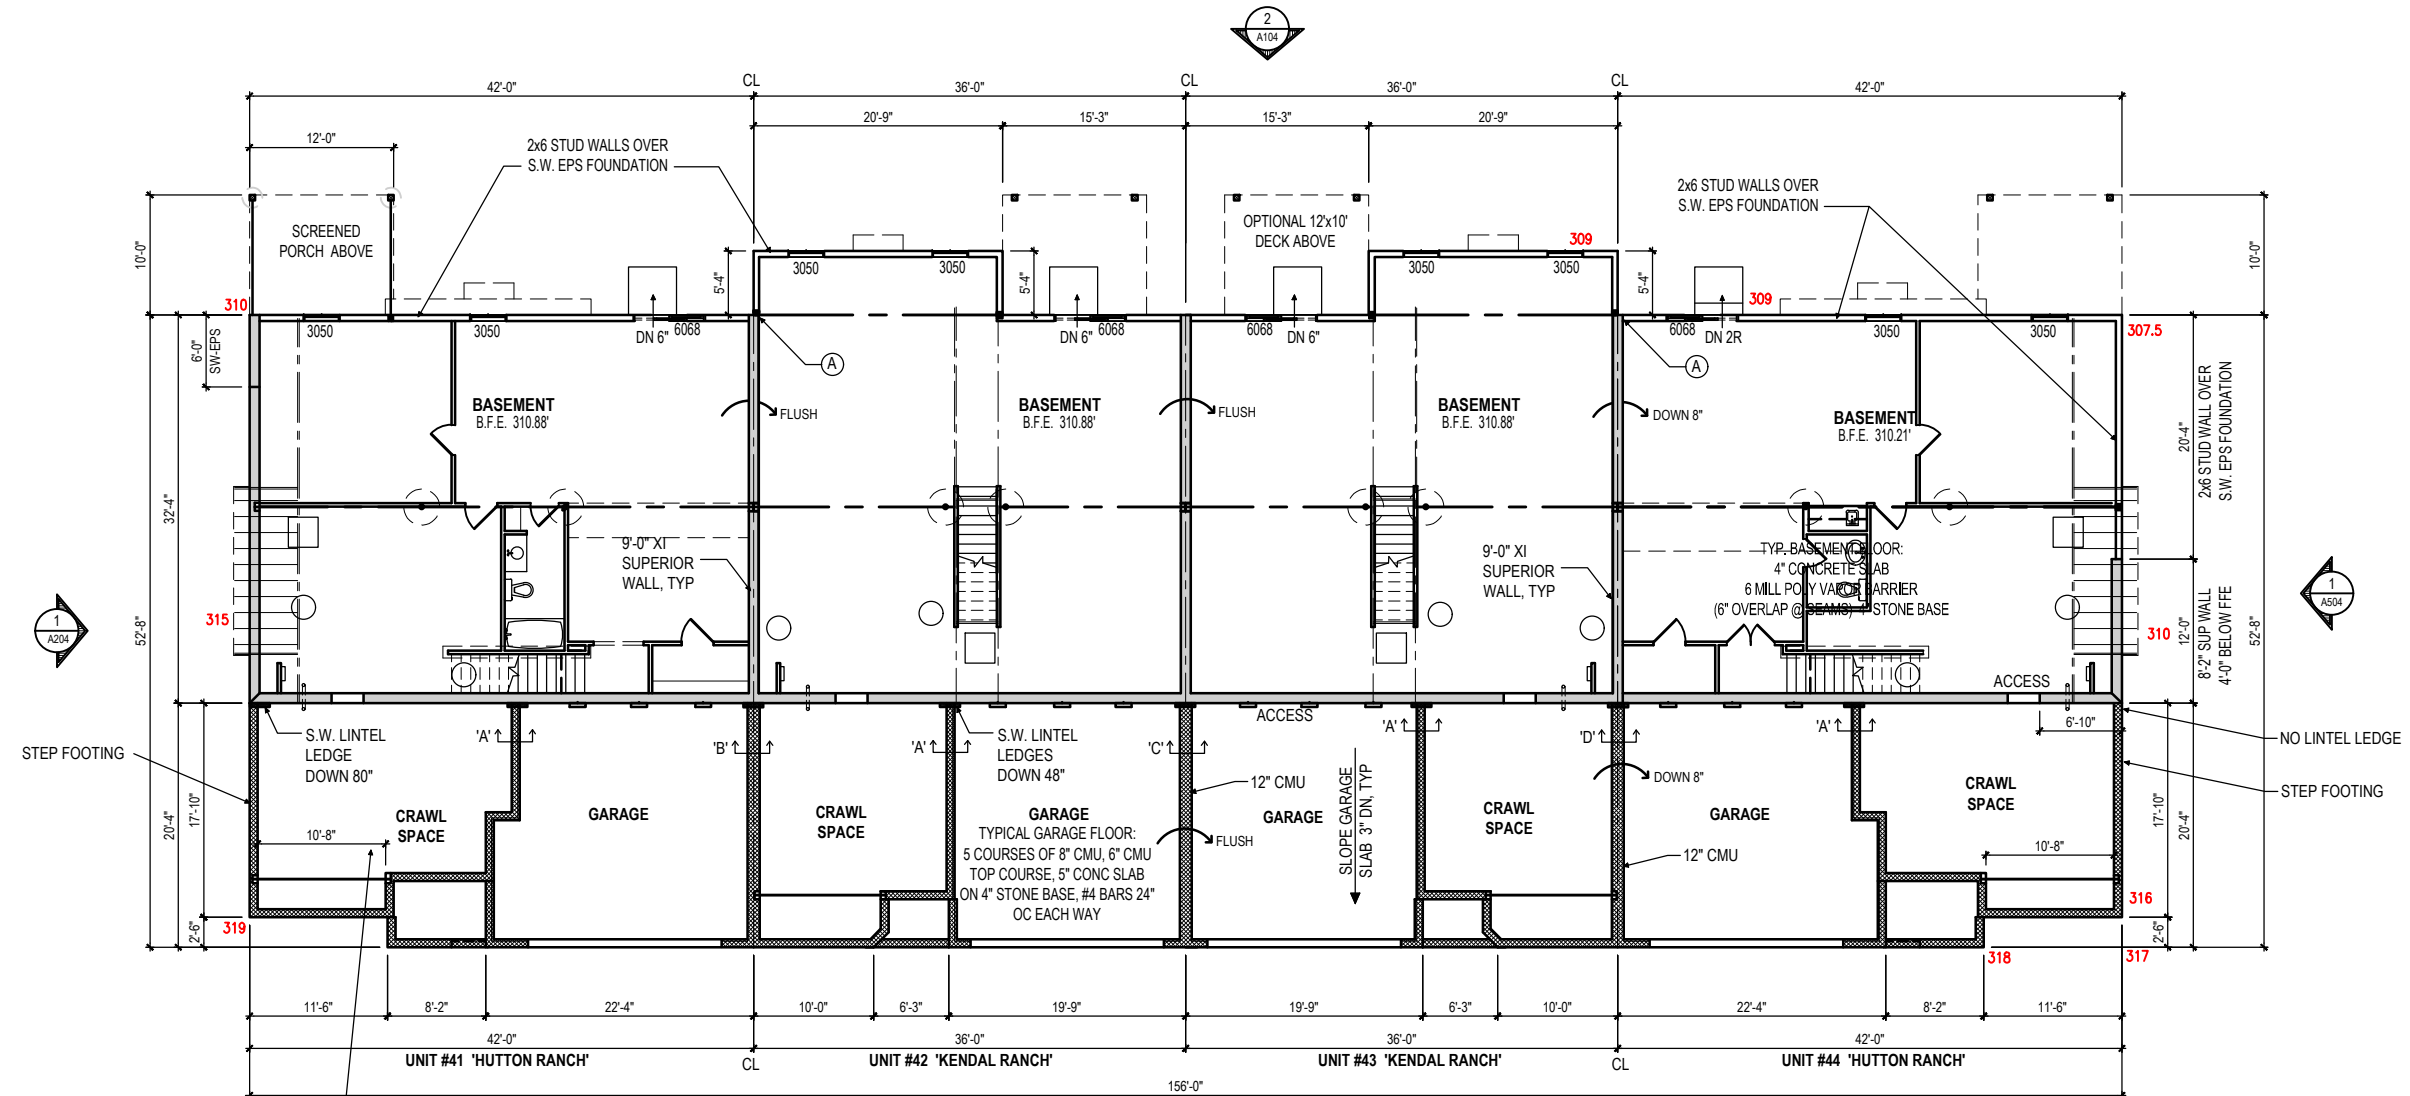


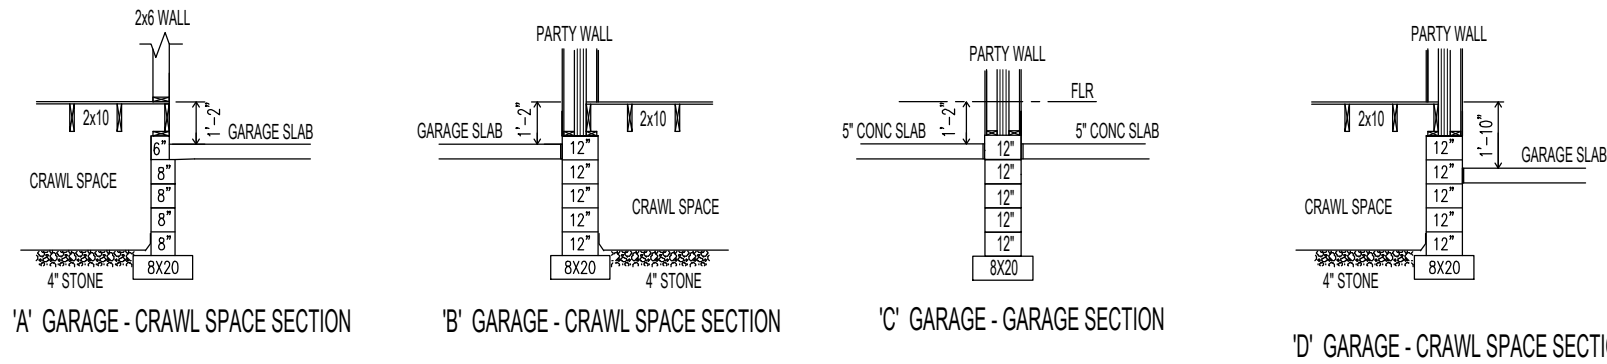

TYPICAL CRAWL SPACE:
INSTALL VERTICAL RADON VENT PIPES PER IRC APPENDIX 'F'.
INSULATE WALLS PER IRC SECTION N1102.2.9, 6 MILL POLY
VAPOR BARRIER. OVERLAP @ SEAMS & TAPE EDGES 6\"/>

OVERALL BASEMENT / FOUNDATION PLAN

SCALE: 1/16\"/>

SEE ALSO ENLARGED INDIVIDUAL UNIT PLANS

KEY NOTES

- (A) WHERE FRAME WALL MEETS CONCRETE, END STUD
TO BE TREATED AND GLUED (TYP)

THIS DRAWING IS THE PROPERTY AND
COPYRIGHT OF MILLFIELD CONSTRUCTION
COMPANY AND MAY NOT BE USED OR COPIED
WITHOUT THE EXPRESS WRITTEN PERMISSION
OF MILLFIELD CONSTRUCTION COMPANY

Millfield
CONSTRUCTION COMPANY
2130 MARIETTA AVENUE
P.O. BOX 6370
LANCASTER, PA 17603
717-293-0293

(4) UNIT TOWNHOUSE:
PEREGRINE: UNITS 41-44
4337, 4335, 4333, 4331 HEATHER LANE
COLUMBIA, PA 17512
WEST HEMPFIELD TOWNSHIP

ISSUE DATE:
JUNE 12, 2025

LATEST REVISION
DATE:
SEPTEMBER 23, 2025

PROJECT NO.
NDS 25-38

DWG NO.

A101