


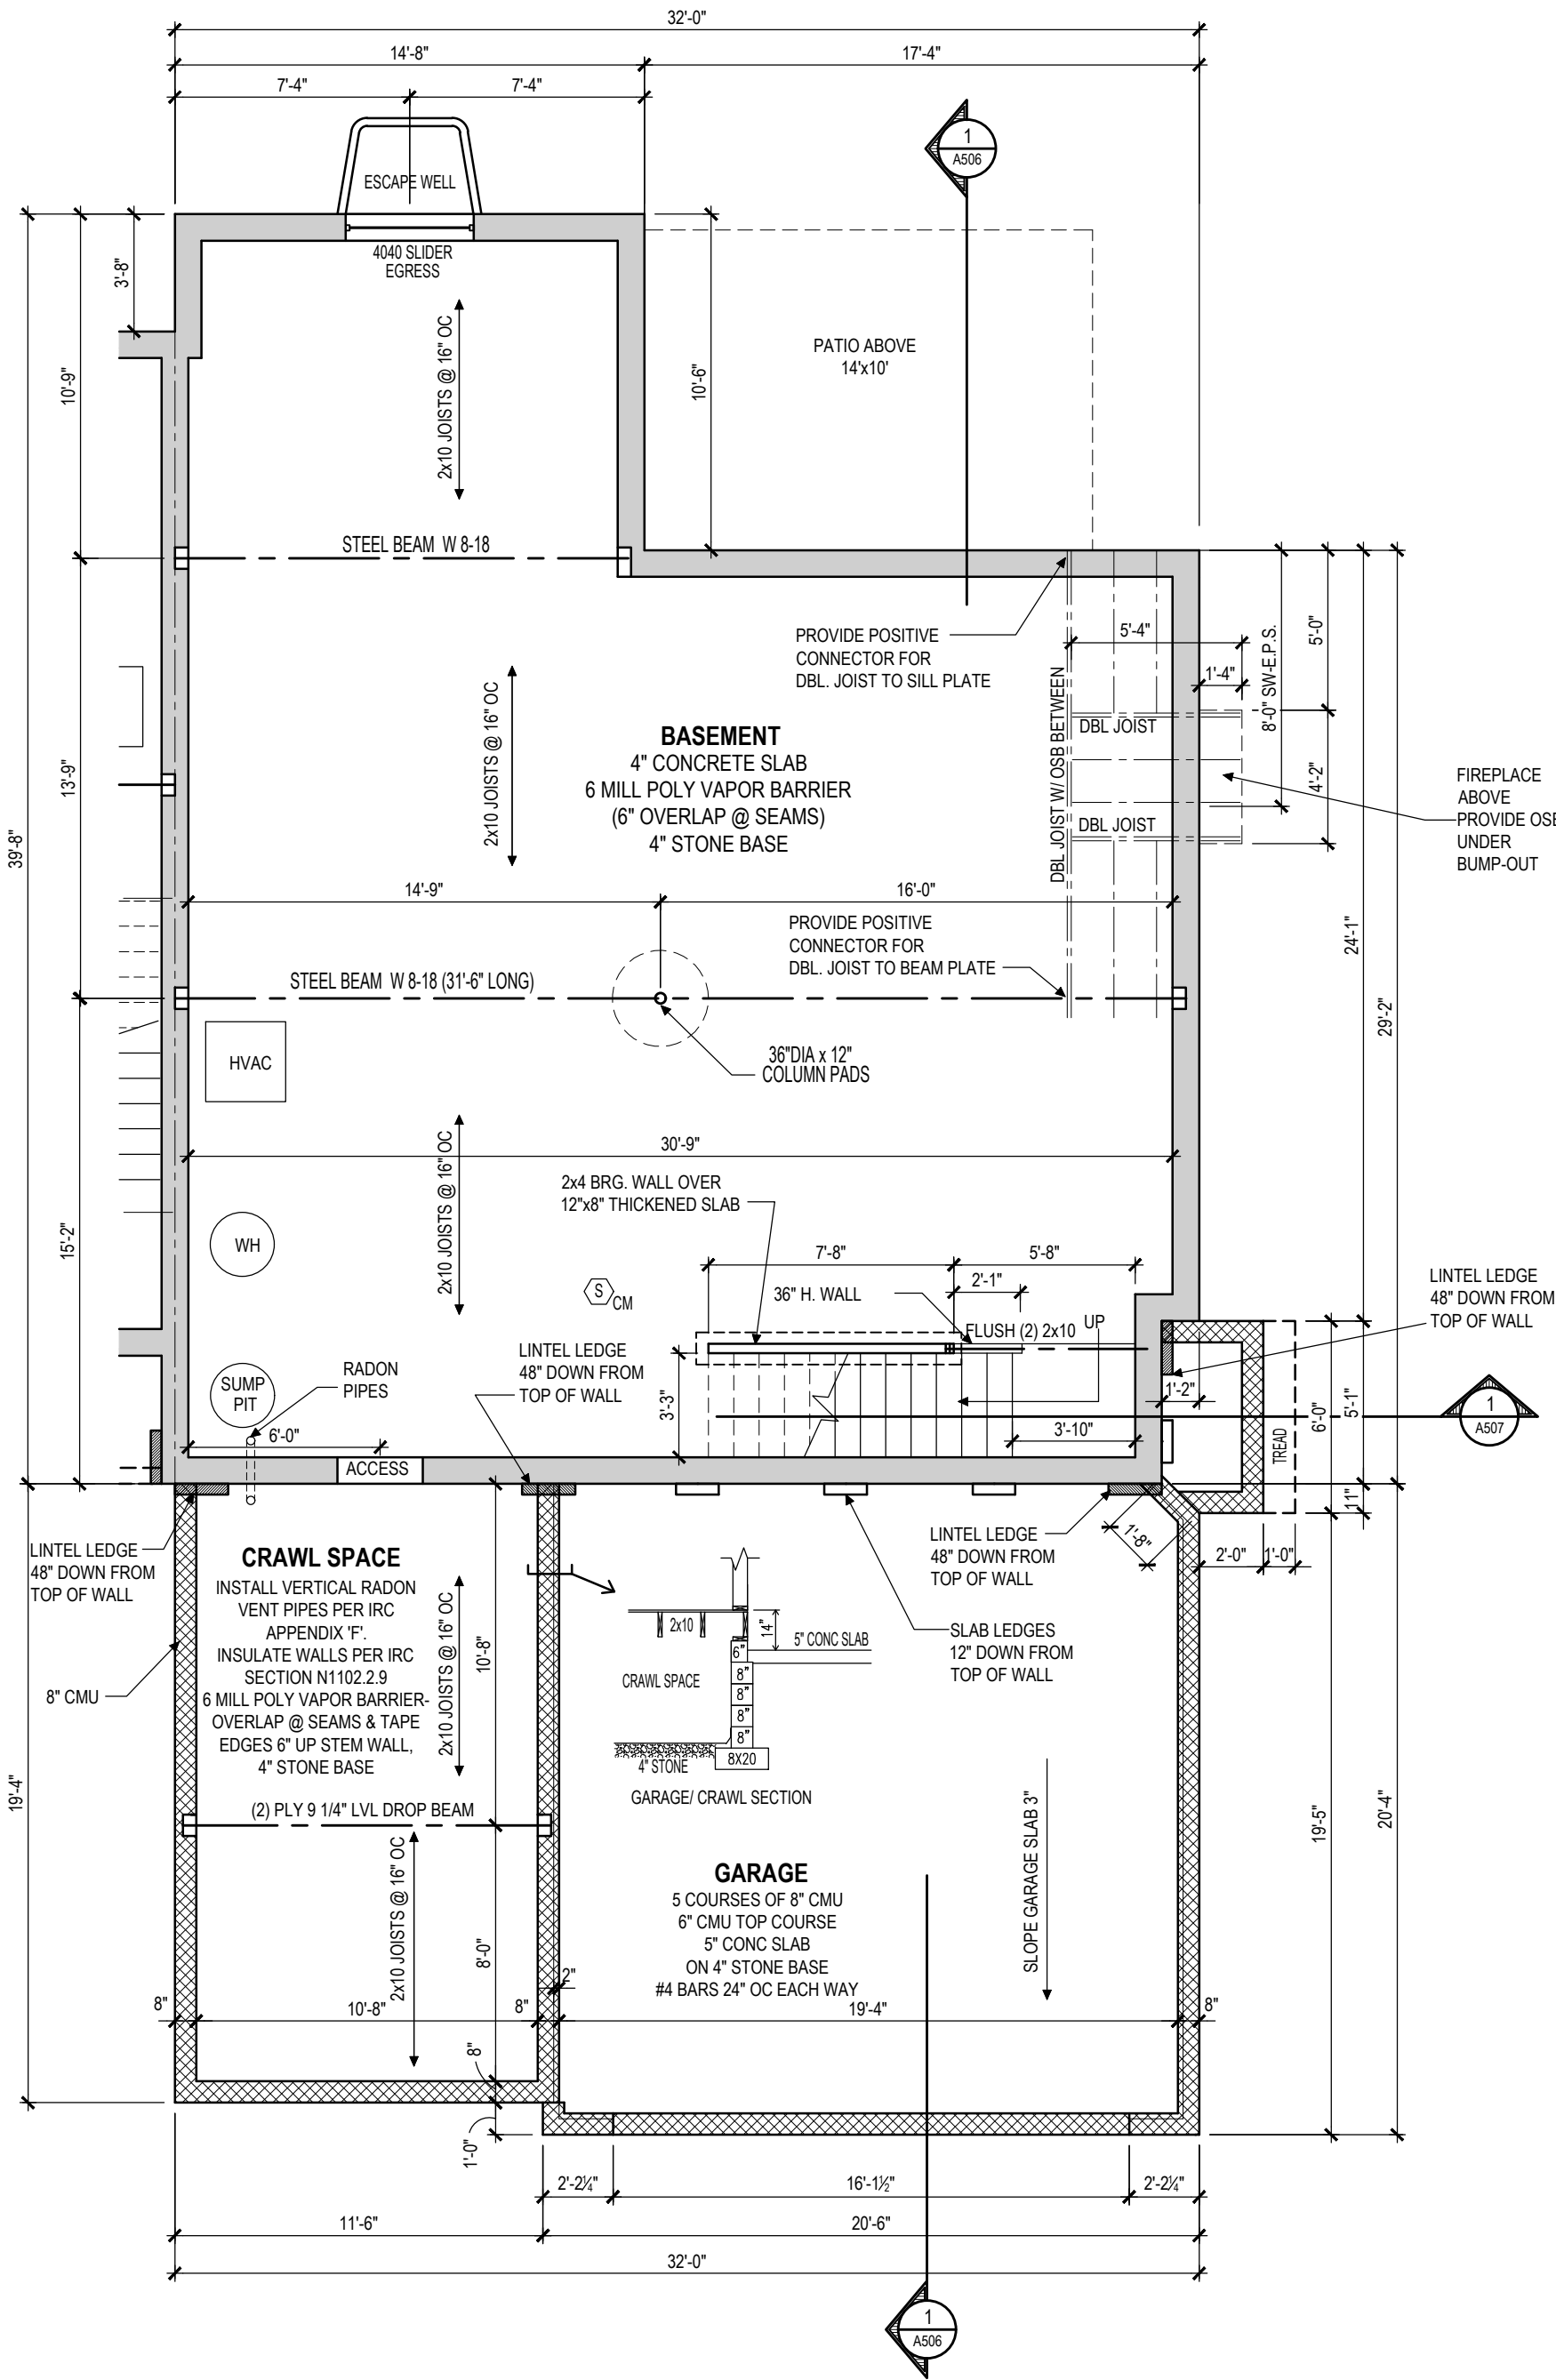


UNIT #58 CARDINAL - BASEMENT-FOUNDATION PLAN

SCALE: 3/16"=1'-0"

A501

DWG. NO.
PROJECT NO.
NDS 23-74
SEPTEMBER 14, 2023
DATE:
JULY 19, 2023
LATEST REVISION

 (4) UNIT TOWNHOUSE AT:
PEREGRINE: CARDINAL #58
829 TALON WAY
COLUMBIA, PA 17512
WEST HEMPFIELD TOWNSHIP



Millfield
CONSTRUCTION COMPANY
2130 MARIETTA AVENUE
P.O. BOX 6370
LANCASTER, PA 17603
717-293-0293

THIS DRAWING IS THE PROPERTY AND
COPYRIGHT OF MILLFIELD CONSTRUCTION
COMPANY AND MAY NOT BE USED OR COPIED
WITHOUT THE EXPRESS WRITTEN PERMISSION
OF MILLFIELD CONSTRUCTION COMPANY